

<b>LEGEND</b>	<b>SWITCHES</b>	<b>MEDIA POINTS</b>	<b>SOCKETS &amp; SPURED POWER OUTLETS</b>	<b>LIGHTING</b>	<b>OTHER</b>
	1 WAY LIGHT SWITCH	TV COAX POINT	SINGLE SOCKET	CEILING LIGHT (PENDANT OR AS SPEC)	THERMOSTAT
	2 WAY LIGHT SWITCH	SATELLITE TV POINT	DOUBLE SOCKET	CEILING LIGHT ON RAIL / BAR ARROWS INDICATE FIT DIRECTION	CONSUMER UNIT
	3 WAY LIGHT SWITCH	TELEPHONE POINT	SINGLE USB SOCKET	INSET CEILING LIGHT (DOWNLIGHT)	CEILING EXTRACTOR FAN
	DIMMER DIMMER LIGHT SWITCH	<b>ALARMS</b>	DOUBLE USB SOCKET	SMALL INSET LIGHT	WALL EXTRACTOR FAN
	1 SWITCH APPLIANCE PLATE	SMOKE ALARM	POP UP SOCKET	LIGHT UNDER CABINET/SHELVES	CEILING SPEAKER
	2 SWITCH APPLIANCE PLATE	SA			
	3 SWITCH APPLIANCE PLATE	SA			
	COOKER CONTROL POINT	CO			
		CARBON MONOXIDE ALARM			

**CONTACT**  
 01495 244 472  
 sales@stately-albion.co.uk  
 www.stately-albion.co.uk

**Stately-Albion Ltd**  
 Prince Of Wales Ind Est  
 Abercarn  
 Newport  
 NP11 5AR

**ISSUED ?:**


**ORDER No:**  
 00/

**000**

**AMENDMENT No:**  
 0


HOME MODEL:  
**-THE HARDWICK-**

SHEET NAME:  
**EXTERIOR ELEVATIONS**

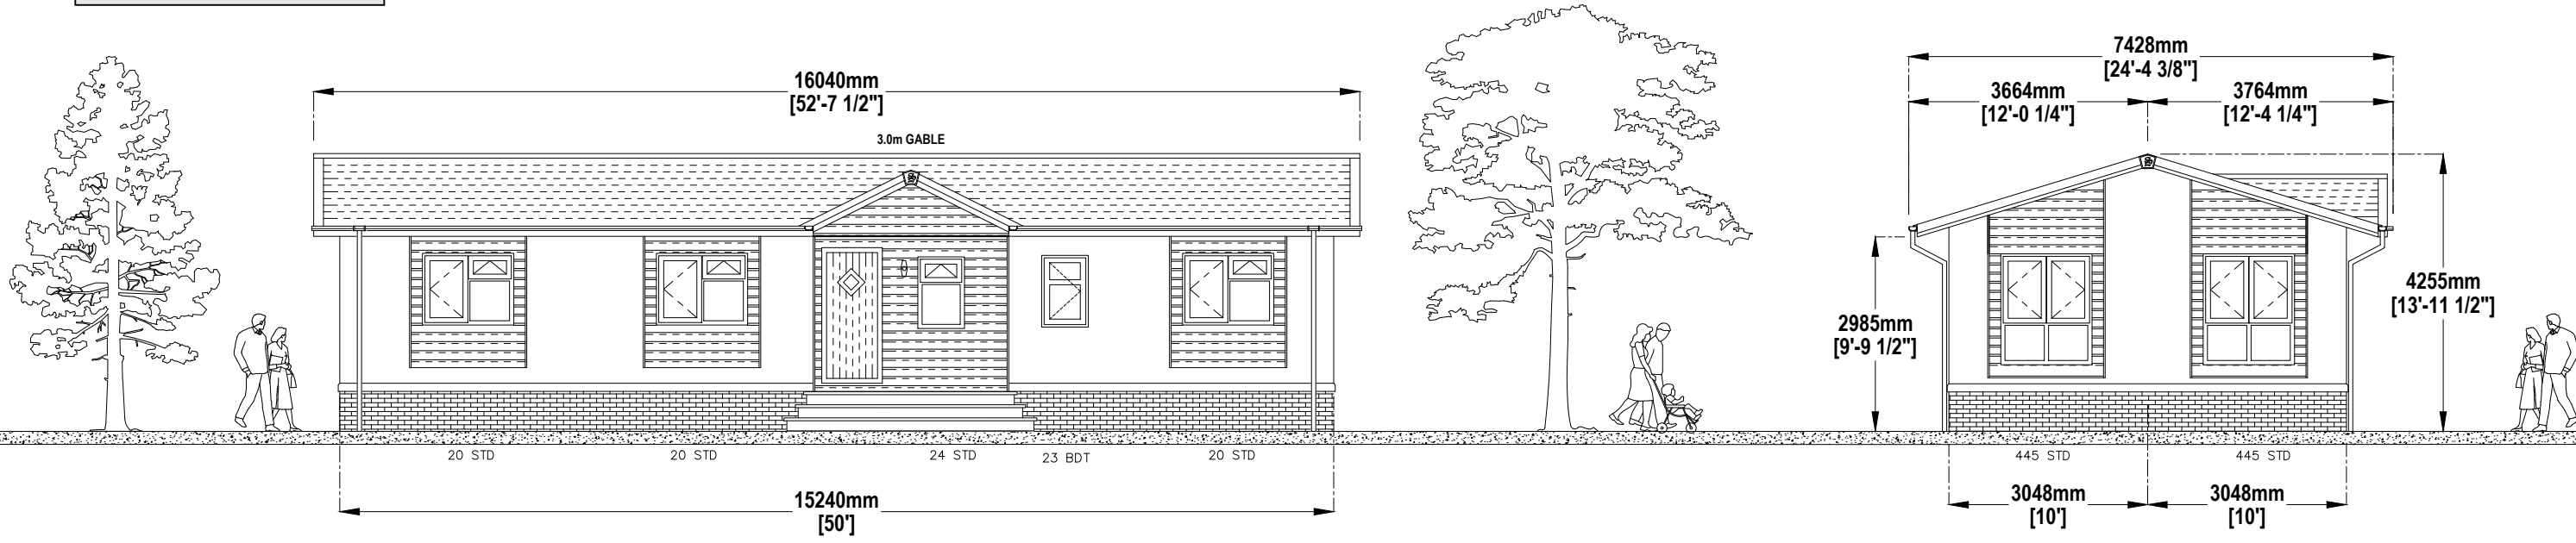

**D**  
**-EXTERIOR-**

**A**  
**-EXTERIOR-**

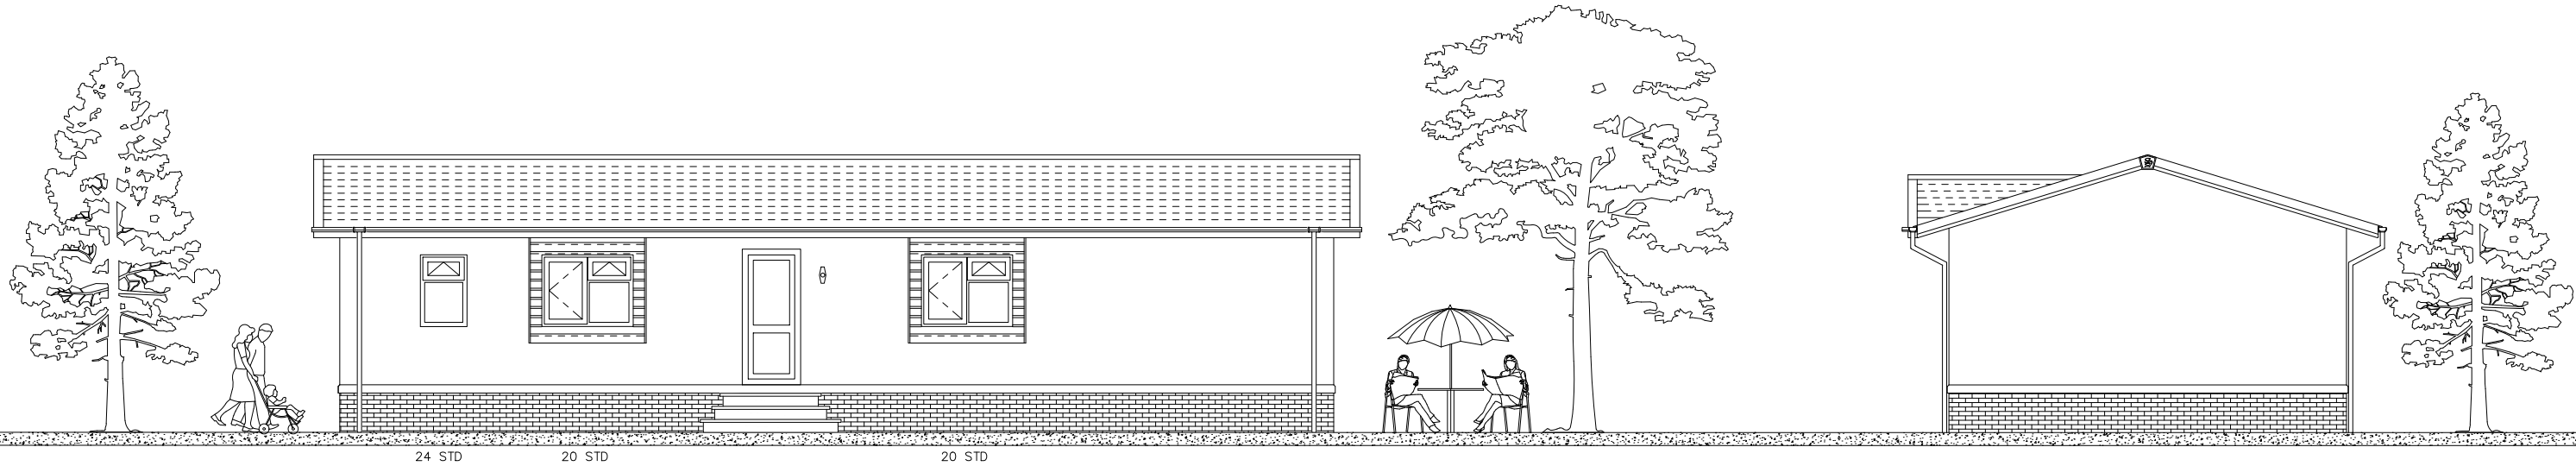

**C**  
**-EXTERIOR-**

**B**  
**-EXTERIOR-**



<b>DRAWN BY:</b>	DD
<b>DATE:</b>	02/01/24

<b>REVISION DATES:</b>	Revised: 00/00/00 (No: 0)	XX	Revised: 00/00/00 (No: 0)	XX	Revised: 00/00/00 (No: 0)	XX	Revised: 00/00/00 (No: 0)	XX
	Revised: 00/00/00 (No: 0)	XX	Revised: 00/00/00 (No: 0)	XX	Revised: 00/00/00 (No: 0)	XX	Revised: 00/00/00 (No: 0)	XX
	Revised: 00/00/00 (No: 0)	XX	Revised: 00/00/00 (No: 0)	XX	Revised: 00/00/00 (No: 0)	XX	Revised: 00/00/00 (No: 0)	XX
	Revised: 00/00/00 (No: 0)	XX	Revised: 00/00/00 (No: 0)	XX	Revised: 00/00/00 (No: 0)	XX	Revised: 00/00/00 (No: 0)	XX

<b>SCALE:</b>	A1	1:25
	A3	1:50

<b>CLIENT</b>	<b>NAME:</b>	JIM FURY	(REF: LONG CARRENT VIEWS)
	<b>CUSTOMER SIGNATURE:</b>		
	<b>ESTIMATE No:</b>	*****	<b>DRAWING No:</b> 30735

<b>LEGEND</b>	<b>SWITCHES</b>	<b>MEDIA POINTS</b>	<b>SOCKETS &amp; SPURED POWER OUTLETS</b>	<b>LIGHTING</b>	<b>OTHER</b>	
	1 WAY LIGHT SWITCH 2 WAY LIGHT SWITCH 3 WAY LIGHT SWITCH DIMMER DIMMER LIGHT SWITCH 1 SWITCH APPLIANCE PLATE 2 SWITCH APPLIANCE PLATE 3 SWITCH APPLIANCE PLATE COOKER CONTROL POINT	TV COAX POINT SATELITE TV POINT TELEPHONE POINT <b>ALARMS</b> SMOKE ALARM CARBON MONOXIDE ALARM	SINGLE SOCKET DOUBLE SOCKET SINGLE USB SOCKET DOUBLE USB SOCKET POP UP SOCKET	SINGLE EXTERIOR SOCKET DOUBLE EXTERIOR SOCKET SHOWER POINT SPURED POWER OUTLET	CEILING LIGHT (PENDANT OR AS SPEC) CEILING LIGHT ON RAIL / BAR INSET CEILING LIGHT (DOORLIGHT) SMALL INSET LIGHT LIGHT UNDER CABINET/SHELVES	OTHER THERMOSTAT CONSUMER UNIT CEILING EXTRACTOR FAN WALL EXTRACTOR FAN CEILING SPEAKER
				CEILING LIGHT ON RAIL / BAR ARROWS INDICATE FIT DIRECTION WALL LIGHT (ALL TYPES) BULKHEAD LIGHT (ATTICS) EXTERIOR LIGHT	OTHER THERMOSTAT CONSUMER UNIT CEILING EXTRACTOR FAN WALL EXTRACTOR FAN CEILING SPEAKER	

**CONTACT**  
 01495 244 472  
 sales@stately-albion.co.uk  
 www.stately-albion.co.uk

**Stately-Albion Ltd**  
 Prince Of Wales Ind Est  
 Abercarn  
 Newport  
 NP11 5AR

**ISSUED ?**  
 X

**ORDER No:** 00/  
**000**  
**AMENDMENT No:** 0

HOME MODEL:  
**-THE HARDWICK-**


SHEET NAME:  
**CUSTOMER FLOOR PLAN**

**-EXTERIOR-  
 C**

**-EXTERIOR-  
 A**

**-EXTERIOR-  
 B**

**D  
 -EXTERIOR-**

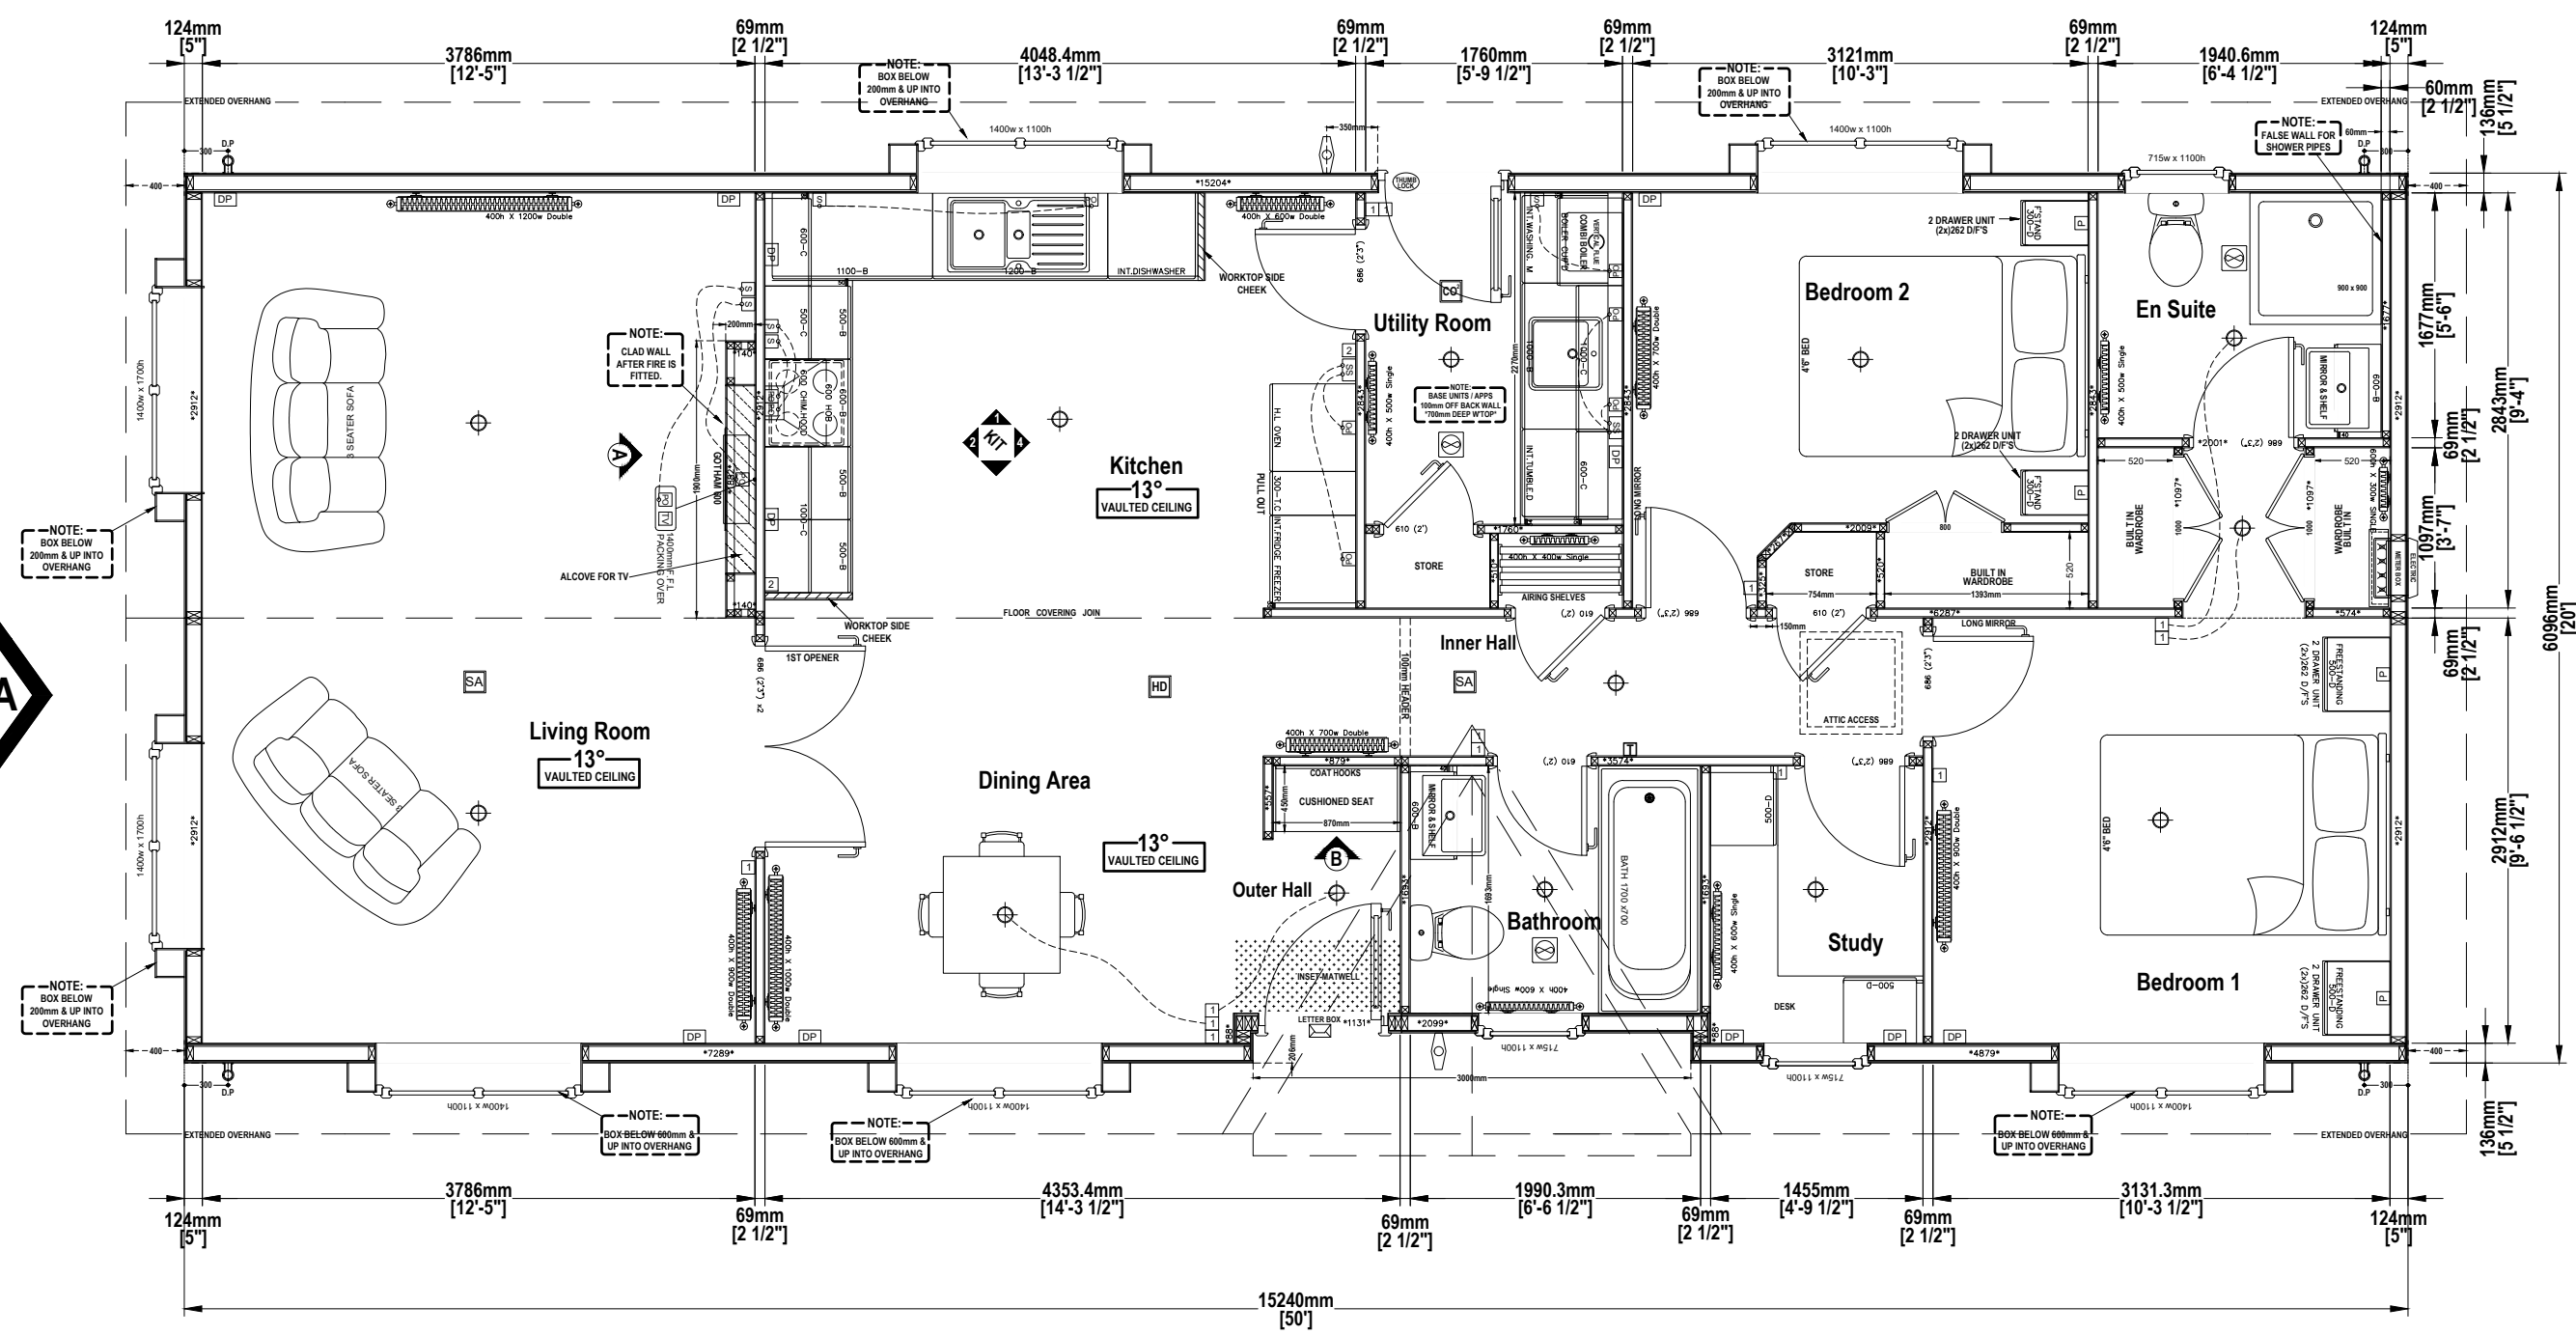

<b>DRAWN BY:</b>	DD
<b>DATE:</b>	02/01/24

<b>REVISION DATES:</b>	Revised: 00/00/00 (No: 0)	XX	Revised: 00/00/00 (No: 0)	XX	Revised: 00/00/00 (No: 0)	XX	Revised: 00/00/00 (No: 0)	XX
	Revised: 00/00/00 (No: 0)	XX	Revised: 00/00/00 (No: 0)	XX	Revised: 00/00/00 (No: 0)	XX	Revised: 00/00/00 (No: 0)	XX
	Revised: 00/00/00 (No: 0)	XX	Revised: 00/00/00 (No: 0)	XX	Revised: 00/00/00 (No: 0)	XX	Revised: 00/00/00 (No: 0)	XX
	Revised: 00/00/00 (No: 0)	XX	Revised: 00/00/00 (No: 0)	XX	Revised: 00/00/00 (No: 0)	XX	Revised: 00/00/00 (No: 0)	XX


<b>SCALE:</b>	A1	1:25
	A3	1:50

<b>CLIENT</b>	<b>NAME:</b>	JIM FURY	(REF: LONG CARENT VIEWS)
	<b>CUSTOMER SIGNATURE:</b>		
	<b>ESTIMATE No:</b>	*****	<b>DRAWING No:</b> 30735

<b>LEGEND</b>	<b>SWITCHES</b>	<b>MEDIA POINTS</b>	<b>SOCKETS &amp; SPURED POWER OUTLETS</b>	<b>LIGHTING</b>	<b>OTHER</b>
	1 WAY LIGHT SWITCH	TV COAX POINT	SINGLE SOCKET	CEILING LIGHT (PENDANT OR AS SPEC)	THERMOSTAT
	2 WAY LIGHT SWITCH	SATELLITE TV POINT	DOUBLE SOCKET	CEILING LIGHT ON RAIL / BAR ARROWS INDICATE FIT DIRECTION	CONSUMER UNIT
	3 WAY LIGHT SWITCH	TELEPHONE POINT	SINGLE USB SOCKET	INSET CEILING LIGHT (DOWNLIGHT)	CEILING EXTRACTOR FAN
	BIMMER DAMPER LIGHT SWITCH	<b>ALARMS</b>	DOUBLE USB SOCKET	SMALL INSET LIGHT	WALL EXTRACTOR FAN
	1 SWITCH APPLIANCE PLATE	SMOKE ALARM	POP UP SOCKET	LIGHT UNDER CABINET/SHELVES	CEILING SPEAKER
	2 SWITCH APPLIANCE PLATE	CARBON MONOXIDE ALARM			
	3 SWITCH APPLIANCE PLATE				
	COOKER CONTROL POINT				

**CONTACT**  
 01495 244 472  
 sales@stately-albion.co.uk  
 www.stately-albion.co.uk

**Stately-Albion Ltd**  
 Prince Of Wales Ind Est  
 Abercam  
 Newport  
 NP11 5AR


ISSUED ?:  


ORDER No:  
 00/

000


AMENDMENT No:  
 0

SHEET NAME:  
**KITCHEN ELEVATIONS**

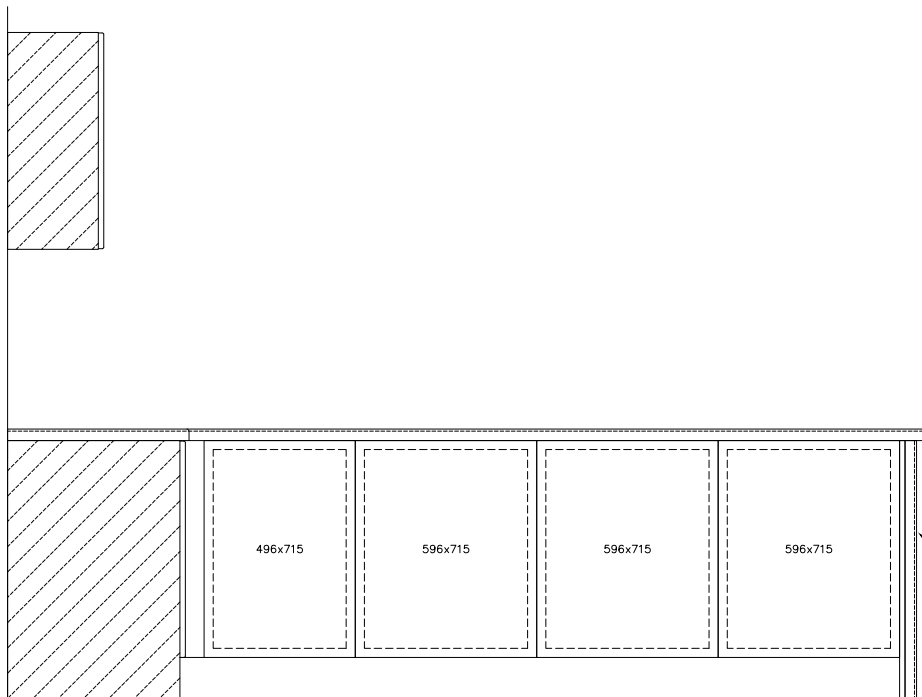


**1** KITCHEN ELEVATION

WORKTOP SIDE CHEEK

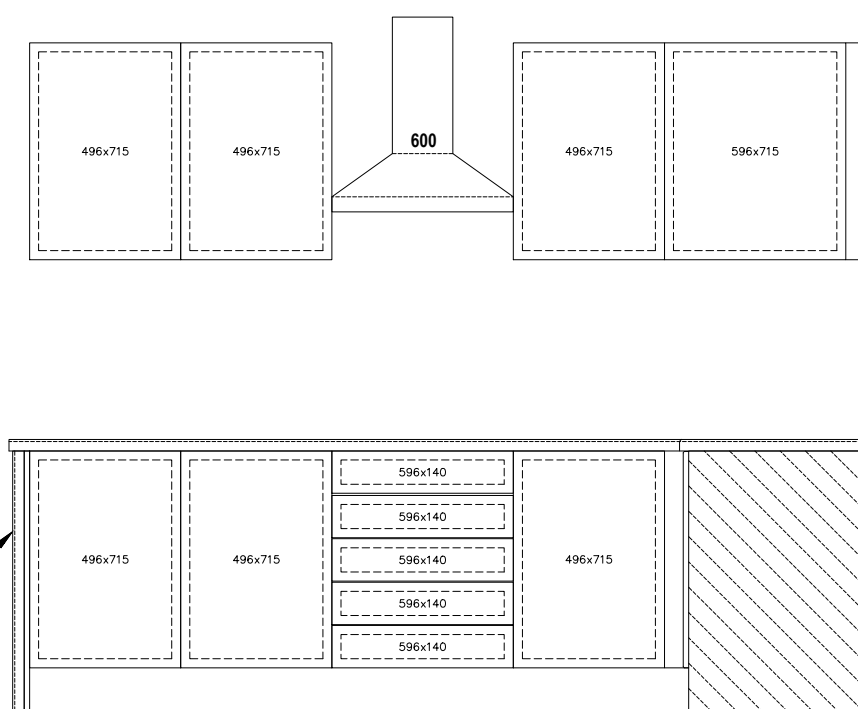


**2** KITCHEN ELEVATION

WORKTOP SIDE CHEEK

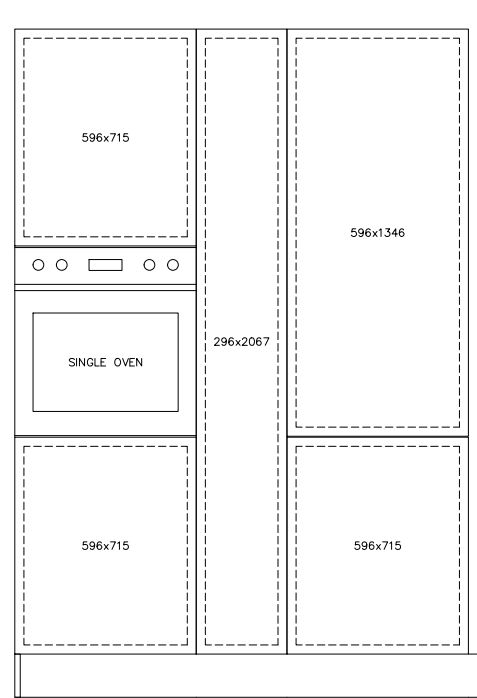

**4** KITCHEN ELEVATION

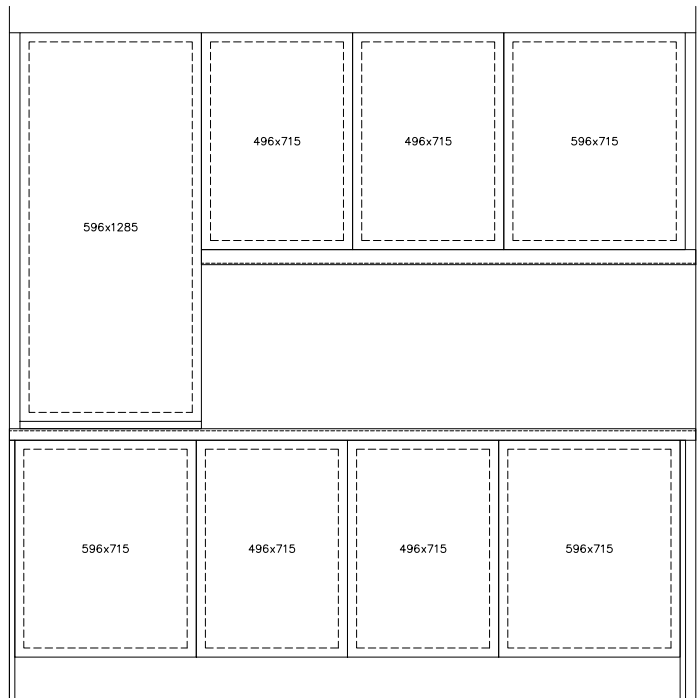

**1** UTILITY ELEVATION



DRAWN BY: DD  
 DATE: 02/01/24

<b>REVISION DATES:</b>	Revised: 00/00/00 (No: 0)	XX	Revised: 00/00/00 (No: 0)	XX	Revised: 00/00/00 (No: 0)	XX	Revised: 00/00/00 (No: 0)	XX
	Revised: 00/00/00 (No: 0)	XX	Revised: 00/00/00 (No: 0)	XX	Revised: 00/00/00 (No: 0)	XX	Revised: 00/00/00 (No: 0)	XX
	Revised: 00/00/00 (No: 0)	XX	Revised: 00/00/00 (No: 0)	XX	Revised: 00/00/00 (No: 0)	XX	Revised: 00/00/00 (No: 0)	XX
	Revised: 00/00/00 (No: 0)	XX	Revised: 00/00/00 (No: 0)	XX	Revised: 00/00/00 (No: 0)	XX	Revised: 00/00/00 (No: 0)	XX


SCALE:  
 A1 1:25  
 A3 1:50

<b>CLIENT</b>	NAME:	JIM FURY	(REF: LONG CARENT VIEWS)
	CUSTOMER SIGNATURE:		
	ESTIMATE No:	*****	DRAWING No: 30735 REV: 1

LEGEND	SWITCHES		MEDIA POINTS		SOCKETS & SPURED POWER OUTLETS		LIGHTING		OTHER			
	1	1 WAY LIGHT SWITCH	TV	TV COAX POINT	P	SINGLE SOCKET	⊙	CEILING LIGHT (PENDANT OR AS SPEC)	P.L	LIGHT IN PLINTH / STEPS	T	THERMOSTAT
	2	2 WAY LIGHT SWITCH	TV	SATELLITE TV POINT	DP	DOUBLE SOCKET	⊙	CEILING LIGHT ON RAIL / BAR (ARROWS INDICATE FIT DIRECTION)	⊙	WALL LIGHT (ALL TYPES)	X X X X	CONSUMER UNIT
	3	3 WAY LIGHT SWITCH	TELEPHONE	TELEPHONE POINT	P	SINGLE USB SOCKET	⊙	INSET CEILING LIGHT (DOWNLIGHT)	⊙	BULKHEAD LIGHT (ATTICS)	⊙	CEILING EXTRACTOR FAN
	4	DIMMER DAMPER LIGHT SWITCH	ALARMS		DP	DOUBLE USB SOCKET	⊙	SMALL INSET LIGHT	⊙	EXTERIOR LIGHT	⊙	WALL EXTRACTOR FAN
	5	1 SWITCH APPLIANCE PLATE	SA	SMOKE ALARM	POP	POP UP SOCKET	▽	LIGHT UNDER CABINET/SHELVES			⊙	CEILING SPEAKER
	6	2 SWITCH APPLIANCE PLATE	CO	CARBON MONOXIDE ALARM								
	7	3 SWITCH APPLIANCE PLATE										
	8	COOKER CONTROL POINT										
	9											

**CONTACT**  
 01495 244 472  
 sales@stately-albion.co.uk  
 www.stately-albion.co.uk

**Stately-Albion Ltd**  
 Prince Of Wales Ind Est  
 Abercam  
 Newport  
 NP11 5AR



ISSUED ?  


ORDER No:  
 00/

000

AMENDMENT No:  
 0

SHEET NAME:  
**INTERNAL ELEVATIONS**

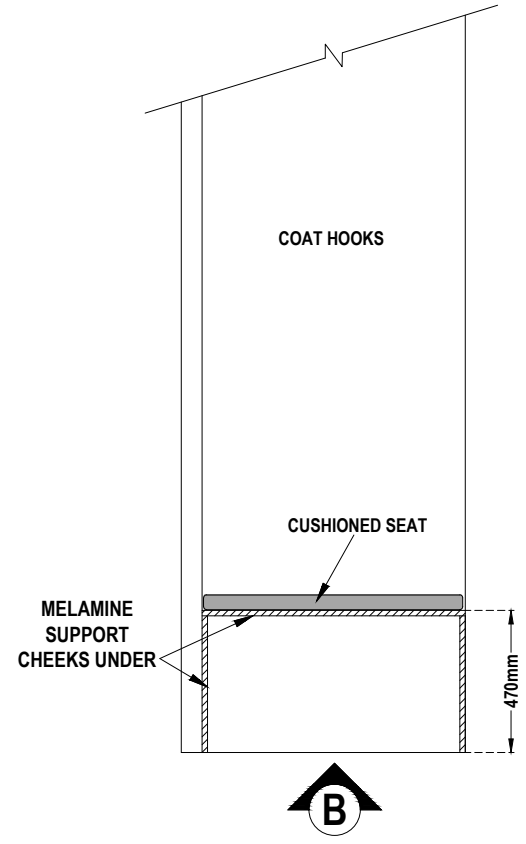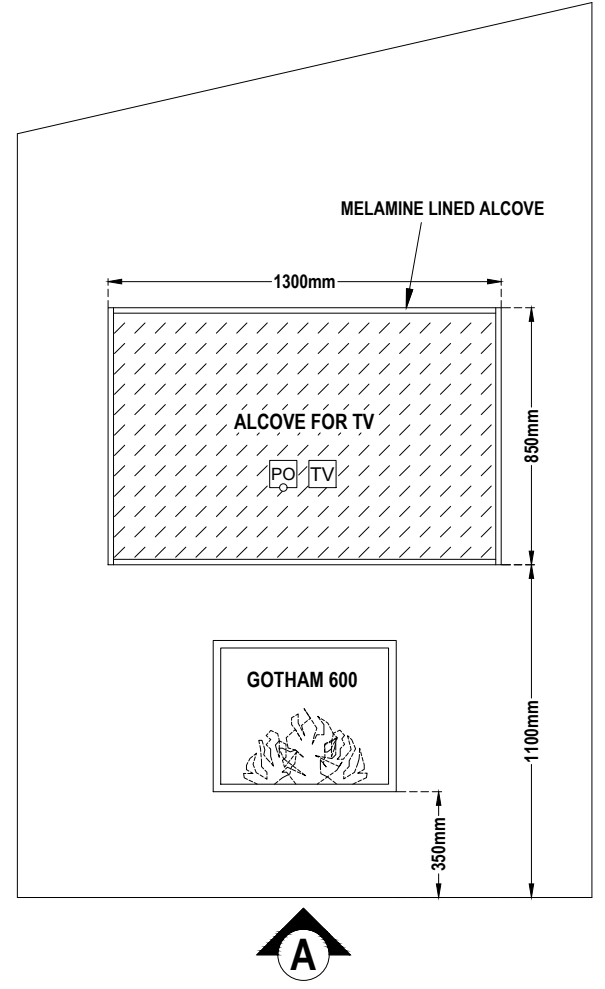

DRAWN BY: DD  
 DATE: 02/01/24

REVISION DATES:	Revised: 00/00/00 (No: 0)	XX	Revised: 00/00/00 (No: 0)	XX	Revised: 00/00/00 (No: 0)	XX	Revised: 00/00/00 (No: 0)	XX
	Revised: 00/00/00 (No: 0)	XX	Revised: 00/00/00 (No: 0)	XX	Revised: 00/00/00 (No: 0)	XX	Revised: 00/00/00 (No: 0)	XX
	Revised: 00/00/00 (No: 0)	XX	Revised: 00/00/00 (No: 0)	XX	Revised: 00/00/00 (No: 0)	XX	Revised: 00/00/00 (No: 0)	XX
	Revised: 00/00/00 (No: 0)	XX	Revised: 00/00/00 (No: 0)	XX	Revised: 00/00/00 (No: 0)	XX	Revised: 00/00/00 (No: 0)	XX

SCALE:  
 A1 1:25  
 A3 1:50

CLIENT	NAME:	JIM FURY (REF: LONG CARENT VIEWS)			
	CUSTOMER SIGNATURE:				
	ESTIMATE No:	*****	DRAWING No:	30735	REV: 1